


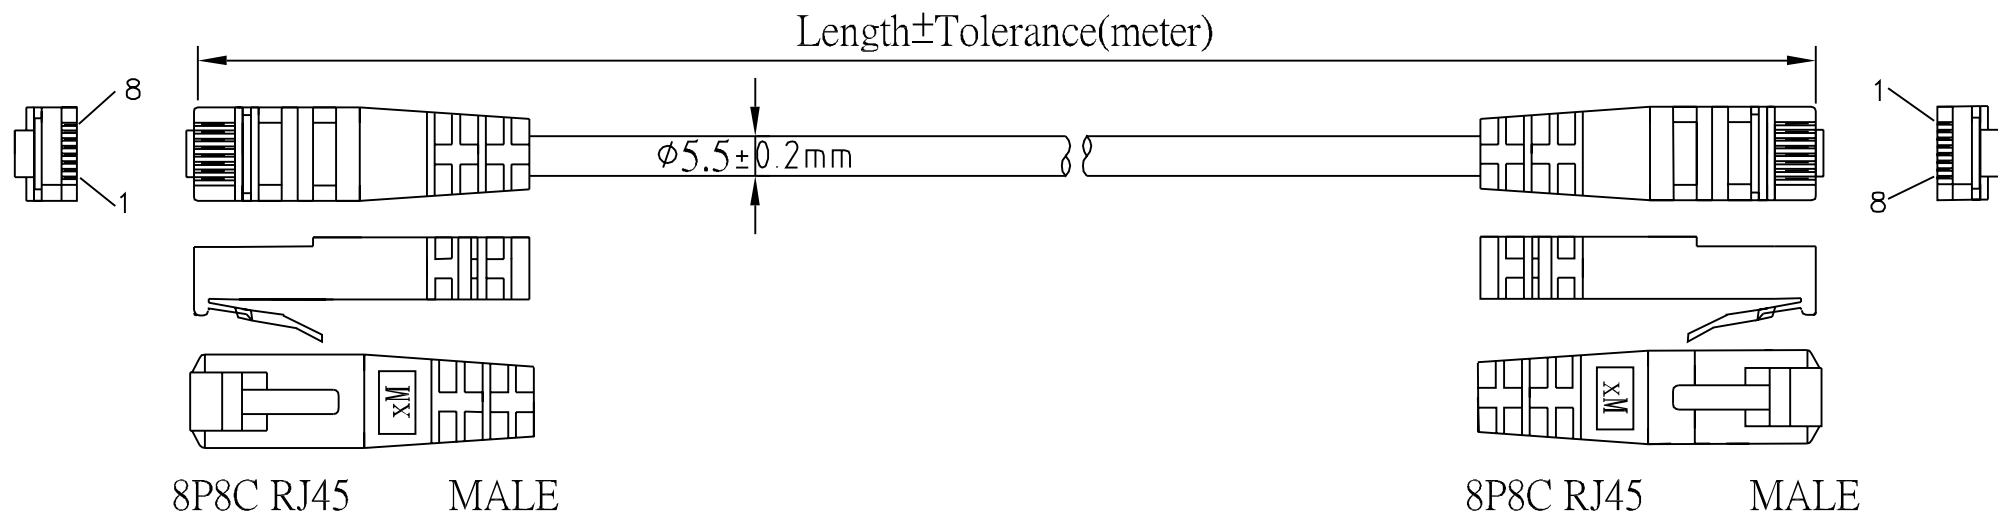

NOTE:

1. CABLE: 26AWG,CAT.5E , SFTP-FOIL,4PAIR,STRANDED,BLACK COLOR,OD=5.5 mm,PVC JACKET.  
meet RoHS,equip printing on jacket.
2. LENGTH:Length printing on plug to go with the real length of the cable.
3. CONNECTOR: 8P8C RJ45 MALE \* 2PCS (ADD BRACKET)
4. MOLD: MOLDING BLACK PVC TYPE
5. CONTACTS:
 

| 8P8C | WIRE         | COLOR | 8P8C   |
|------|--------------|-------|--------|
| 1    | ORANGE/WHITE | 3     | } PAIR |
| 2    | ORANGE       | 6     |        |
| 3    | GREEN/WHITE  | 1     | } PAIR |
| 6    | GREEN        | 2     |        |
| 4    | BLUE         | 7     | } PAIR |
| 5    | BLUE/WHITE   | 8     |        |
| 7    | BROWN/WHITE  | 4     | } PAIR |
| 8    | BROWN        | 5     |        |
| 64   | SHELL        | 64    |        |
6. OPEN/SHORT TEST: 100% TEST.  
INSULATION: 2M.
7. PACKING: 1 PC/ EQUIP ZIP BAG and 10 PCS/NEUTRAL POLYBAG

| ITEM NO | LENGTH | TOLERANCE |
|---------|--------|-----------|
| 705910  | 1.0M   | 0.02M     |
| 705911  | 2.0M   | 0.03M     |
| 705912  | 3.0M   | 0.05M     |
| 705914  | 5.0M   | 0.08M     |
| 705916  | 10M    | 0.10M     |

|          |            |             |             |        |  |   |                                                                                       |             |                                                                                       |
|----------|------------|-------------|-------------|--------|--|---|---------------------------------------------------------------------------------------|-------------|---------------------------------------------------------------------------------------|
| COMPANY  | DDC        |             | ITEM NO.    | 705910 |  | A |                                                                                       |             |                                                                                       |
| REVISION | DATE       | DISCRIPTION | DRAWN BY    |        |  |   |  | SCALE       | NO:                                                                                   |
| REV.A/0  | 2005.04.27 | S-2504041   | DESIGNED BY |        |  |   |                                                                                       | UNIT(mm)    |  |
|          |            |             | APPROVAL BY |        |  |   |                                                                                       | DRAWING NO. |                                                                                       |
|          |            |             |             |        |  |   |                                                                                       |             |                                                                                       |